


STRUCTURE DATA TABLE AS BUILT

STRUCTURE NUMBER	SIZE	LENGTH	FLOW LINE		SLOPE	FES = IE AD = Rim or CI = FG
			UP STREAM	DOWN STREAM		
	in.	ft.	Elev.	Elev.	%	
Wayland Court						
CI #508						399.71
P #509	12	29	397.02	396.61	1.41	
CI #510						399.82
P #511	12	143	396.61	391.61	3.50	
CI #524						396.21
P #525	15	29	393.44	392.98	1.59	
CI #526						396.00
P #527	15	175	392.98	390.01	1.70	
FES #528						390.01

AS-BUILT DATA 9-27-05 DRAINAGE SWALE DATA TABLE

SWALE NUMBER	LENGTH	SLOPE	FLOW LINE		16" x 8" CONCRETE RIBBON
			UP STREAM	DOWN STREAM	
	ft.	%	Elev.	Elev.	
1	78	4.97	398.58	394.70	
2	71	0.80	399.15	398.58	
3	128	1.27	397.35	395.72	
4	122	1.26	397.26	395.72	
5	153	1.02	397.26	395.70	
7	N/A	N/A	N/A	N/A	

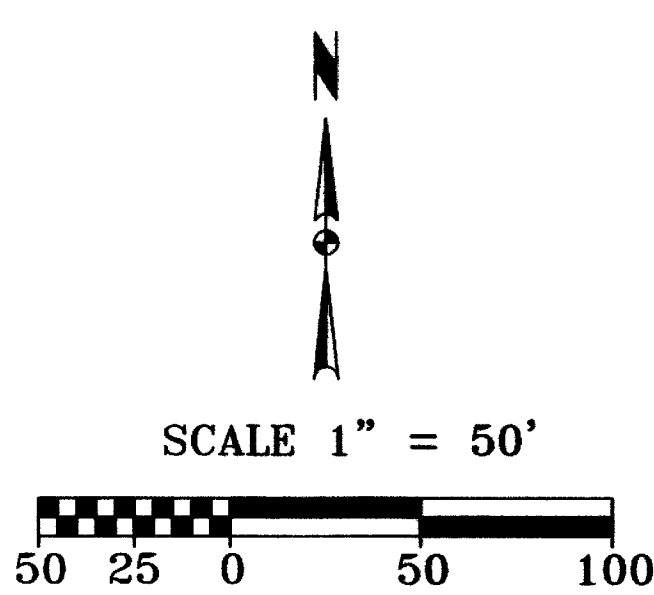

SANITARY SEWER LATERAL INDEX

L = LENGTH OF LATERAL
D = DISTANCE OF LATERAL TO DOWNSTREAM MANHOLE

I, James E. Morley, certify and affirm that the completed storm water drainage system for this project is in general compliance with the Final Drainage Plan as approved by the Vanderburgh County Drainage Board. Except:
1. Swale 7 was not installed at this time. Developer to install at a later date.

James E. Morley
Signature
PE 10100250
Indiana Registration Number

Approx. location of the proposed 100 Year Flood Zone "AE" as parcel plots by scale on Community-Panel Number 18163001080 of the Proposed Flood Insurance Rate Maps for Vanderburgh County.

Approx. location of the 100 Year Flood Zone "A" as parcel plots by scale on Community-Panel Number 180256 0015 C of the Flood Insurance Rate Maps for Vanderburgh County, Dated August 5, 1991.

Engineering
Surveying
Architecture
Construction Management

Morley and Associates Inc.
Evansville, IN
(812) 464-6655
Henderson, KY
(270) 830-0300

www.morleyandassociates.com

No.	By	Date	Description

3-27-07

Bridlewood - Section 6B

Utility/Drainage Plan

Record Drawing

Scale: 1" = 50'

Designed By: JEM Job Number: 5527-4(B)
 Drawn By: BSH Date: 8-27-07

Filename: J:\5527\CH\Drainage\RECORD 6B.dwg
 Sheet Number: 3

3