

ENGINEERING PLANS

CASEY'S OF EVANSVILLE (#3968)


6315 & 6333 VIETH LANE

EVANSVILLE, INDIANA 47725

UTILITY AND GOVERNING AGENCY CONTACTS				
SERVICE / JURISDICTION	COMPANY / DEPT.	ADDRESS	PHONE NUMBER	CONTACT
SANITARY SEWER	EVANSVILLE SEWER DEPARTMENT	1 NW MARTIN LUTHER KING JR BLVD, EVANSVILLE, IN 47708	(812) 421-2126	DOUG OHNING
STORM SEWER	VANDERBURGH COUNTY SURVEYOR	1 NW MARTIN LUTHER KING JR BLVD, #325, EVANSVILLE, IN 47708	(812) 435-5210	LINDA FREEMAN
WATER	EVANSVILLE WATER DEPARTMENT	1 NW MARTIN LUTHER KING JR BLVD, EVANSVILLE, IN 47708	(812) 421-2126	DOUG OHNING
NATURAL GAS	VECTREN		(812) 491-4604	ANN-MARIE SCHAPKER
ELECTRICITY	AMERESCO	2119 WIMBERG AVENUE EVANSVILLE, IN 47720	(812) 422-6788	
TELEPHONE / COMMUNICATIONS	SPECTRUM	1900 N. FARES AVENUE EVANSVILLE, IN 47711	(812) 253-2755	DARYL HULSEY
STREETS	VANDERBURGH COUNTY HIGHWAY DEPARTMENT	5105 N. ST. JOSEPH AVENUE EVANSVILLE, IN 47720	(812) 435-5777	CHRIS SHILLINGER
PLANNING AND ZONING	VANDERBURGH COUNTY AREA PLAN COMMISSION	1 NW MARTIN LUTHER KING JR BLVD, #312, EVANSVILLE, IN 47708	(812) 435-5978	DONNA HOLDERFIELD



PROJECT TEAM				
ROLE	COMPANY	ADDRESS	PHONE NUMBER	CONTACT
DEVELOPER/OWNER	CASEY'S GENERAL STORES	3305 SE DELAWARE AVE, ANKENY, IA 50021	(515) 381-5722	ERIK NIKKEL, PE
CIVIL ENGINEER	KIMLEY-HORN & ASSOCIATES, INC.	250 E. 96TH ST., STE 580, INDIANAPOLIS, IN 46240	(317) 218-9560	CONNOR STREGE, PE
GEOTECHNICAL ENGINEER	ALT & WITZIG ENGINEERING, INC.	6200 E. MAXWELL AVE, SUITE C, EVANSVILLE, IN 47715	(812) 422-4446	PATRICK KNOLL, PE
LAND SURVEYOR	HAMILTON DESIGNS	11 MUNICIPAL DR, SUITE 300, FISHERS, IN 46038	(317) 570-8800	TERRY WRIGHT, PS

LEGAL DESCRIPTION
 LOTS ONE (1) AND TWO (2) IN HECKEL ROAD COMMERCIAL SUBDIVISION, AS PER PLAT THEREOF, RECORDED IN PLAT BOOK U, PAGE 45 IN THE OFFICE OF THE RECORDER OF VANDERBURGH COUNTY, INDIANA

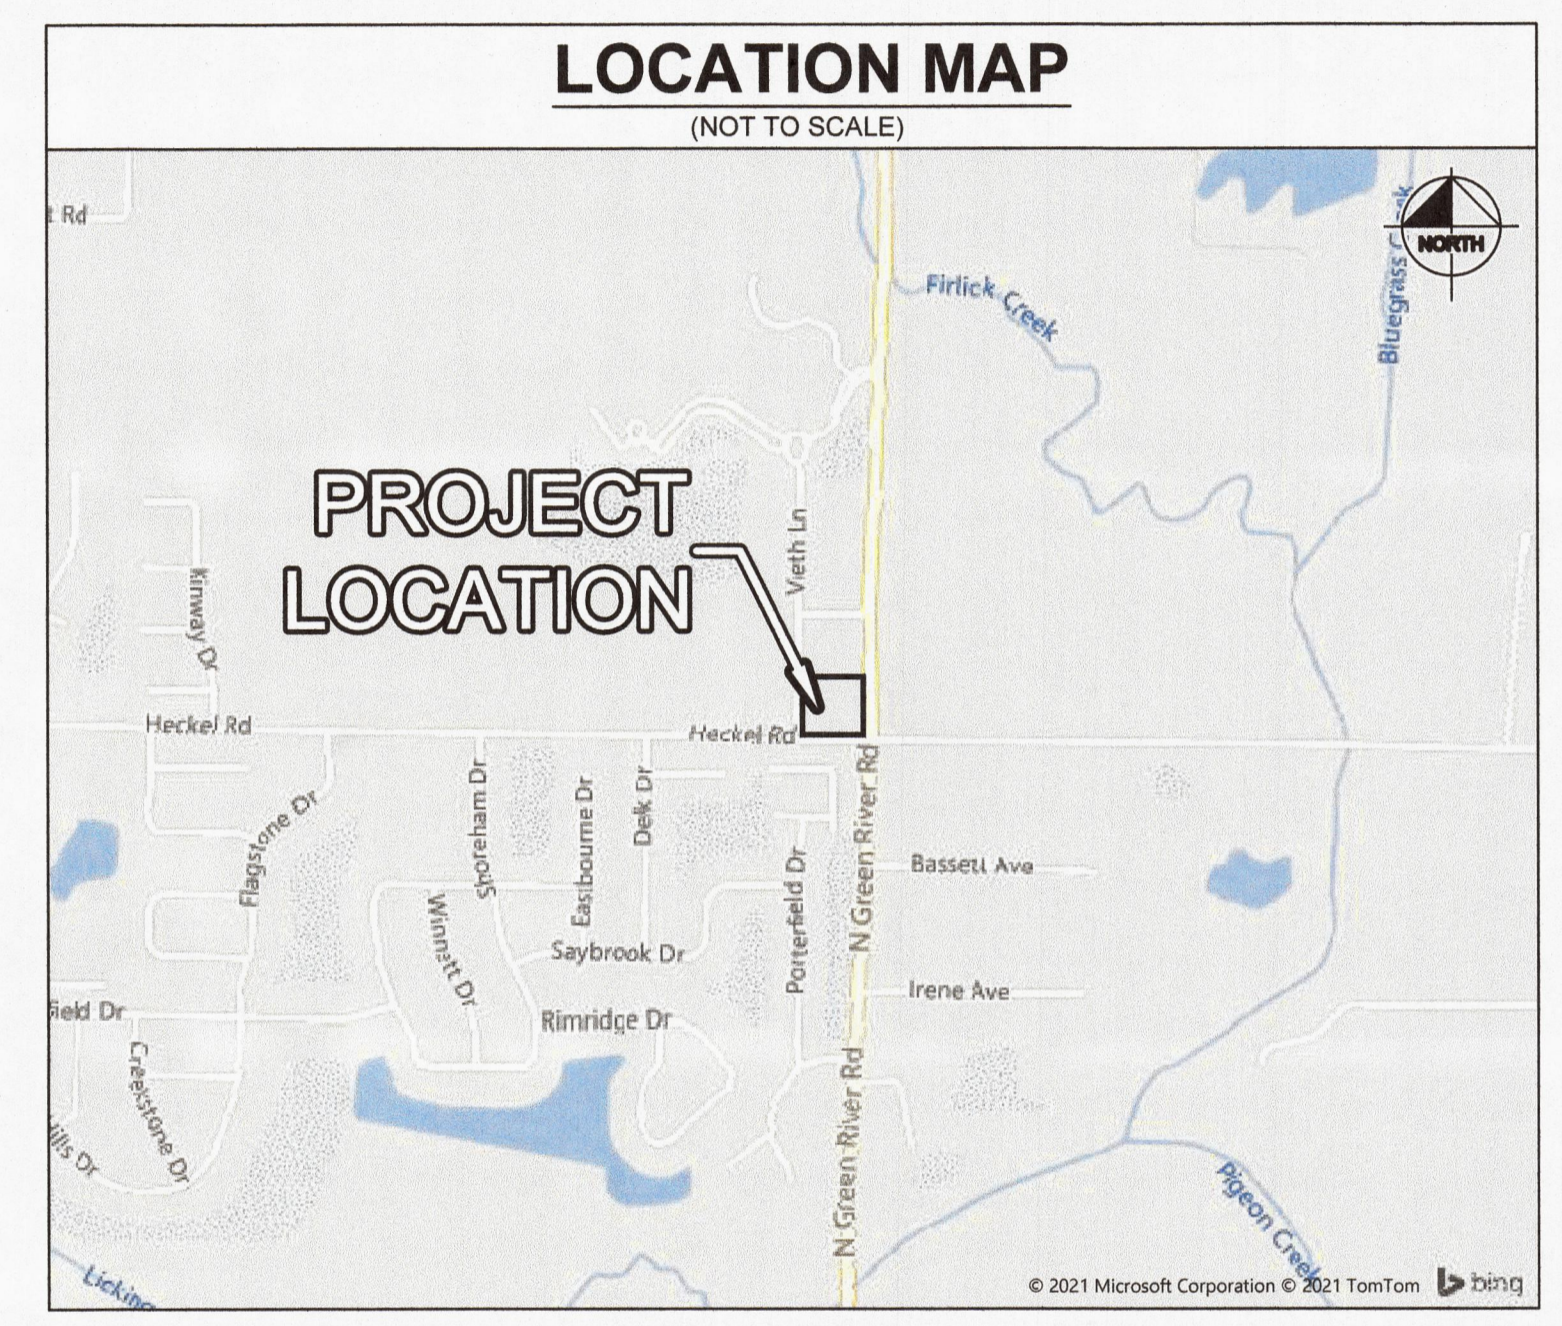

VANDERBURGH COUNTY
 CONSTRUCTION OF A ±3,220 SF COMMERCIAL BUILDING FOR CASEY'S GENERAL STORES ON ±1.82 AC. PROJECT IS IN SECTION 35 OF T5S, R10W IN EVANSVILLE, VANDERBURGH COUNTY, INDIANA

SHEET INDEX	
SHEET NO.	SHEET TITLE
C-001	COVER SHEET
C-002	GENERAL SPECIFICATIONS
C-003	GENERAL NOTES
C-004	ALTA TITLE SURVEY
C-005	ALTA TITLE SURVEY
C-100	DEMOLITION PLAN
C-101	SITE PLAN
C-201	GRADING AND DRAINAGE PLAN
C-301	UTILITY PLAN
C-302	STRUCTURE DATA TABLES
C-401	INITIAL EROSION CONTROL PLAN
C-402	TEMPORARY EROSION CONTROL PLAN
C-403	FINAL EROSION CONTROL PLAN
C-404	EROSION CONTROL DETAILS
C-405	SWPPP
C-601	CONSTRUCTION DETAILS
C-602	CONSTRUCTION DETAILS
C-603	CONSTRUCTION DETAILS
C-604	CONSTRUCTION DETAILS
C-605	CONSTRUCTION DETAILS
RL-6811-S1-R4	LIGHTING PLAN

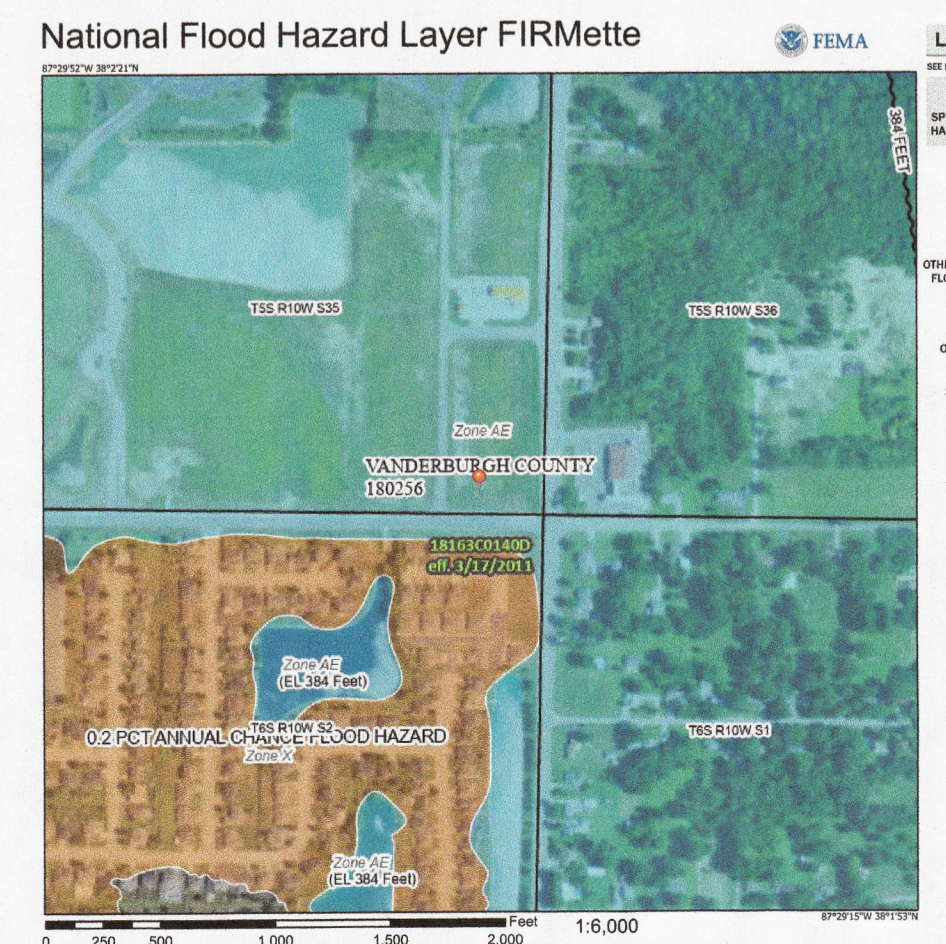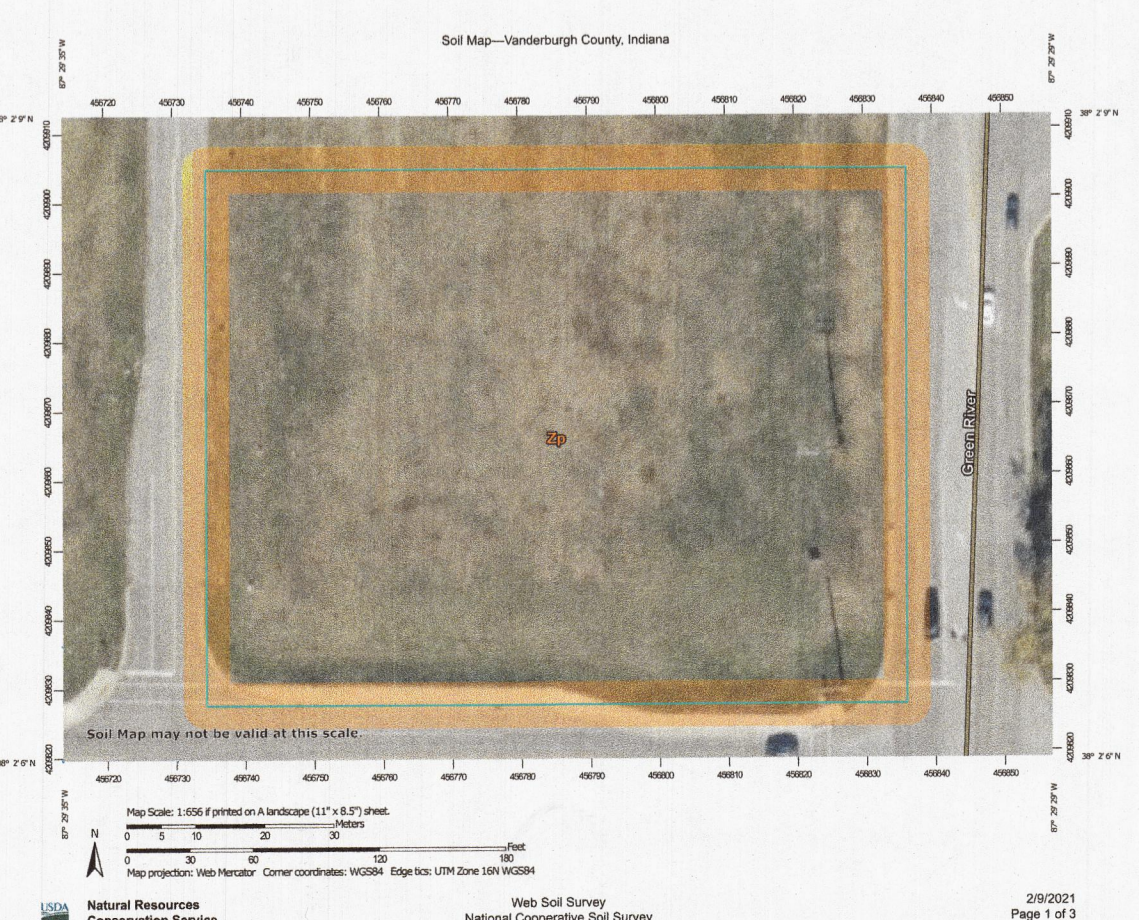

APPROVED

DEC 13 2022

VANDERBURGH COUNTY DRAINAGE BOARD

Received by the Vanderburgh County Surveyor's Office

NOV 29 2022


Time 10:03 AM Initials AR

COUNTY COMMENTS	CITY COMMENTS	UTILITY/CLIENT COMMENTS	CITY COMMENTS	REVISIONS
11/28/22	10/31/22	09/26/22	07/30/21	06/25/21
CVS	DIG	CMB	CVS	CVS
DATE	DATE	DATE	DATE	DATE

Kimley-Horn
 ©2022 KIMLEY-HORN AND ASSOCIATES, INC.
 250 EAST 96TH STREET, SUITE 580,
 INDIANAPOLIS, IN 46240
 WWW.KIMLEY-HORN.COM

SCALE: AS NOTED
 DESIGNED BY: CVS
 DRAWN BY: RCB
 CHECKED BY: ART

REGISTERED PROFESSIONAL ENGINEER
 CONNOR STREGE
 NOT APPROVED FOR CONSTRUCTION
 11/28/2022

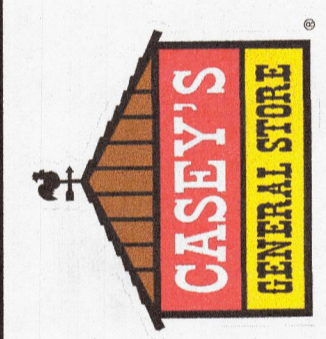

COVER SHEET

CASEY'S OF EVANSVILLE (#3968)

ORIGINAL ISSUE: 03/01/2021

KHA PROJECT NO. 170151001

SHEET NUMBER

C-001