


**NOTE:**  
 ALL DRAINAGE STRUCTURES (I.E. SWALES, STORM SEWER PIPES, INLETS, RETENTION BASIN, ETC.) WILL BE LOCATED IN DEDICATED EASEMENTS CONFORMING TO THE REQUIREMENTS OF THE VANDERBURGH COUNTY DRAINAGE ORDINANCE, ADOPTED NOV. 28, 1984.

SCALES:  
 1" = 50' HOR  
 1" = 5' VER

ASBUILT OF LATERAL LOCATIONS

| LOT # | DOWNSTREAM M.H. | DISTANCE TO M.H. | DISTANCE OFF LINE |
|-------|-----------------|------------------|-------------------|
| 5     | 521             | 328.8            | 10.2              |
| 5     | 521             | 347.7            | 14.75             |
| 7     | 521             | 190.9            | 3.1               |
| 8     | 521             | 122.1            | 5.8               |
| 9     | 521             | 45.1             | 6.3               |
| 10    | 520B            | 314.4            | 7.4               |
| 11    | 520B            | 246              | 5.1               |
| 12    | 520B            | 174.2            | 5.1               |
| 13    | 520B            | 107.1            | 4.2               |
| 14    | 520B            | 41.7             | 5.3               |

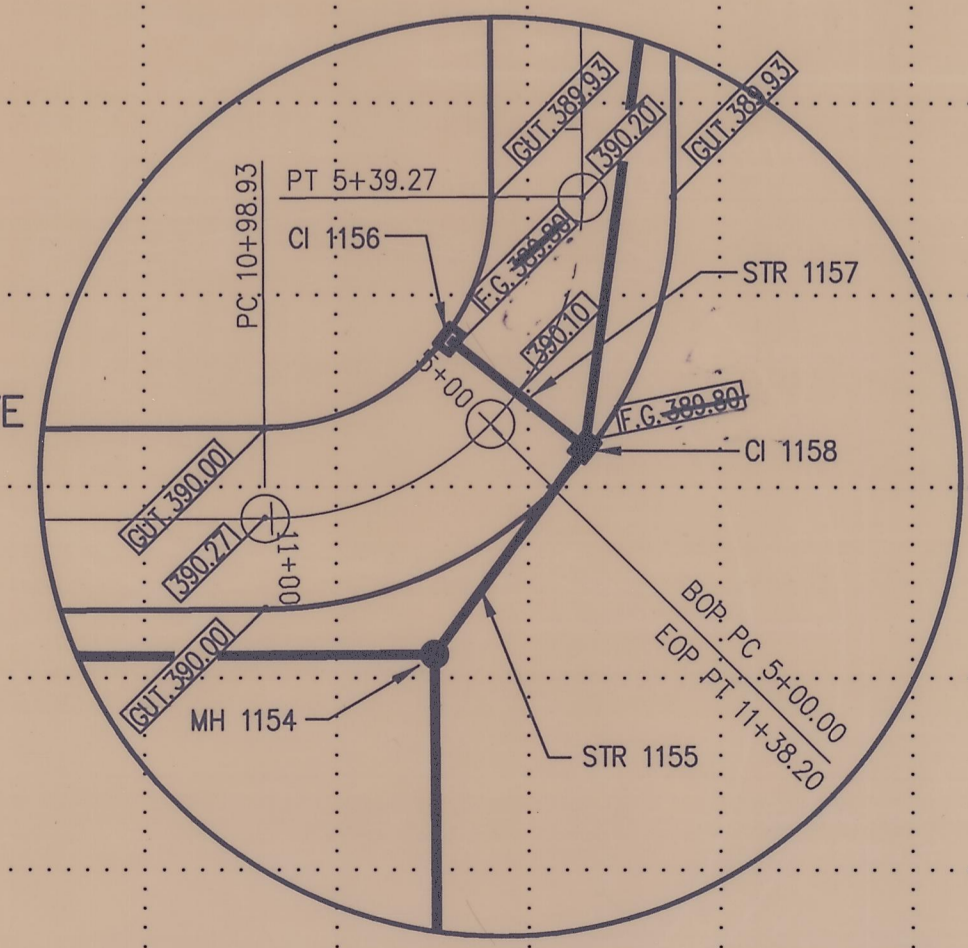

**Note:**  
 All pipes measured center of structure, to center of structure, to the nearest foot. All storm, sanitary and lateral pipes crossing roadway shall have sand backfill under and within 5 feet of pavement.

SCALE: 1" = 30'  
**MERIMAC DRIVE - SOUTHPORT DRIVE**

**Morley and Associates, Inc.**  
 Consulting Engineers/Surveyors/Architects  
 605 S.E. Martin Luther King Jr. Blvd.  
 Evansville, Indiana 47713  
 (812) 484-8666

Project: Clear Creek Village - Section 1  
 Sheet Title: Merimac Drive Plan and Profile  
 Sheet Number: 6

Revisions:

| No. | By     | Date     | Description                               |
|-----|--------|----------|-------------------------------------------|
| 1   | J.E.M. | 4/14/97  | Revised road grades and sewer elevations. |
| 2   | S.C.L. | 08/07/97 | Sanitary Sewer As Built Phase 1           |
| 3   | J.E.M. | 5/21/98  | STORM SEWER AS BUILT 5                    |

Professional Engineer Seal: JAMES Q. MORLEY, No. 13817, STATE OF INDIANA

Hor. Scale: 1" = 50'  
 Ver. Scale: 1" = 5'

Designed By: J.E.M. Job Number: 96-3309-1(A)(A2)  
 Drawn By: G.A.H. Date: 09-27-96  
 Checked By: RCP01002.DWG

of 16