
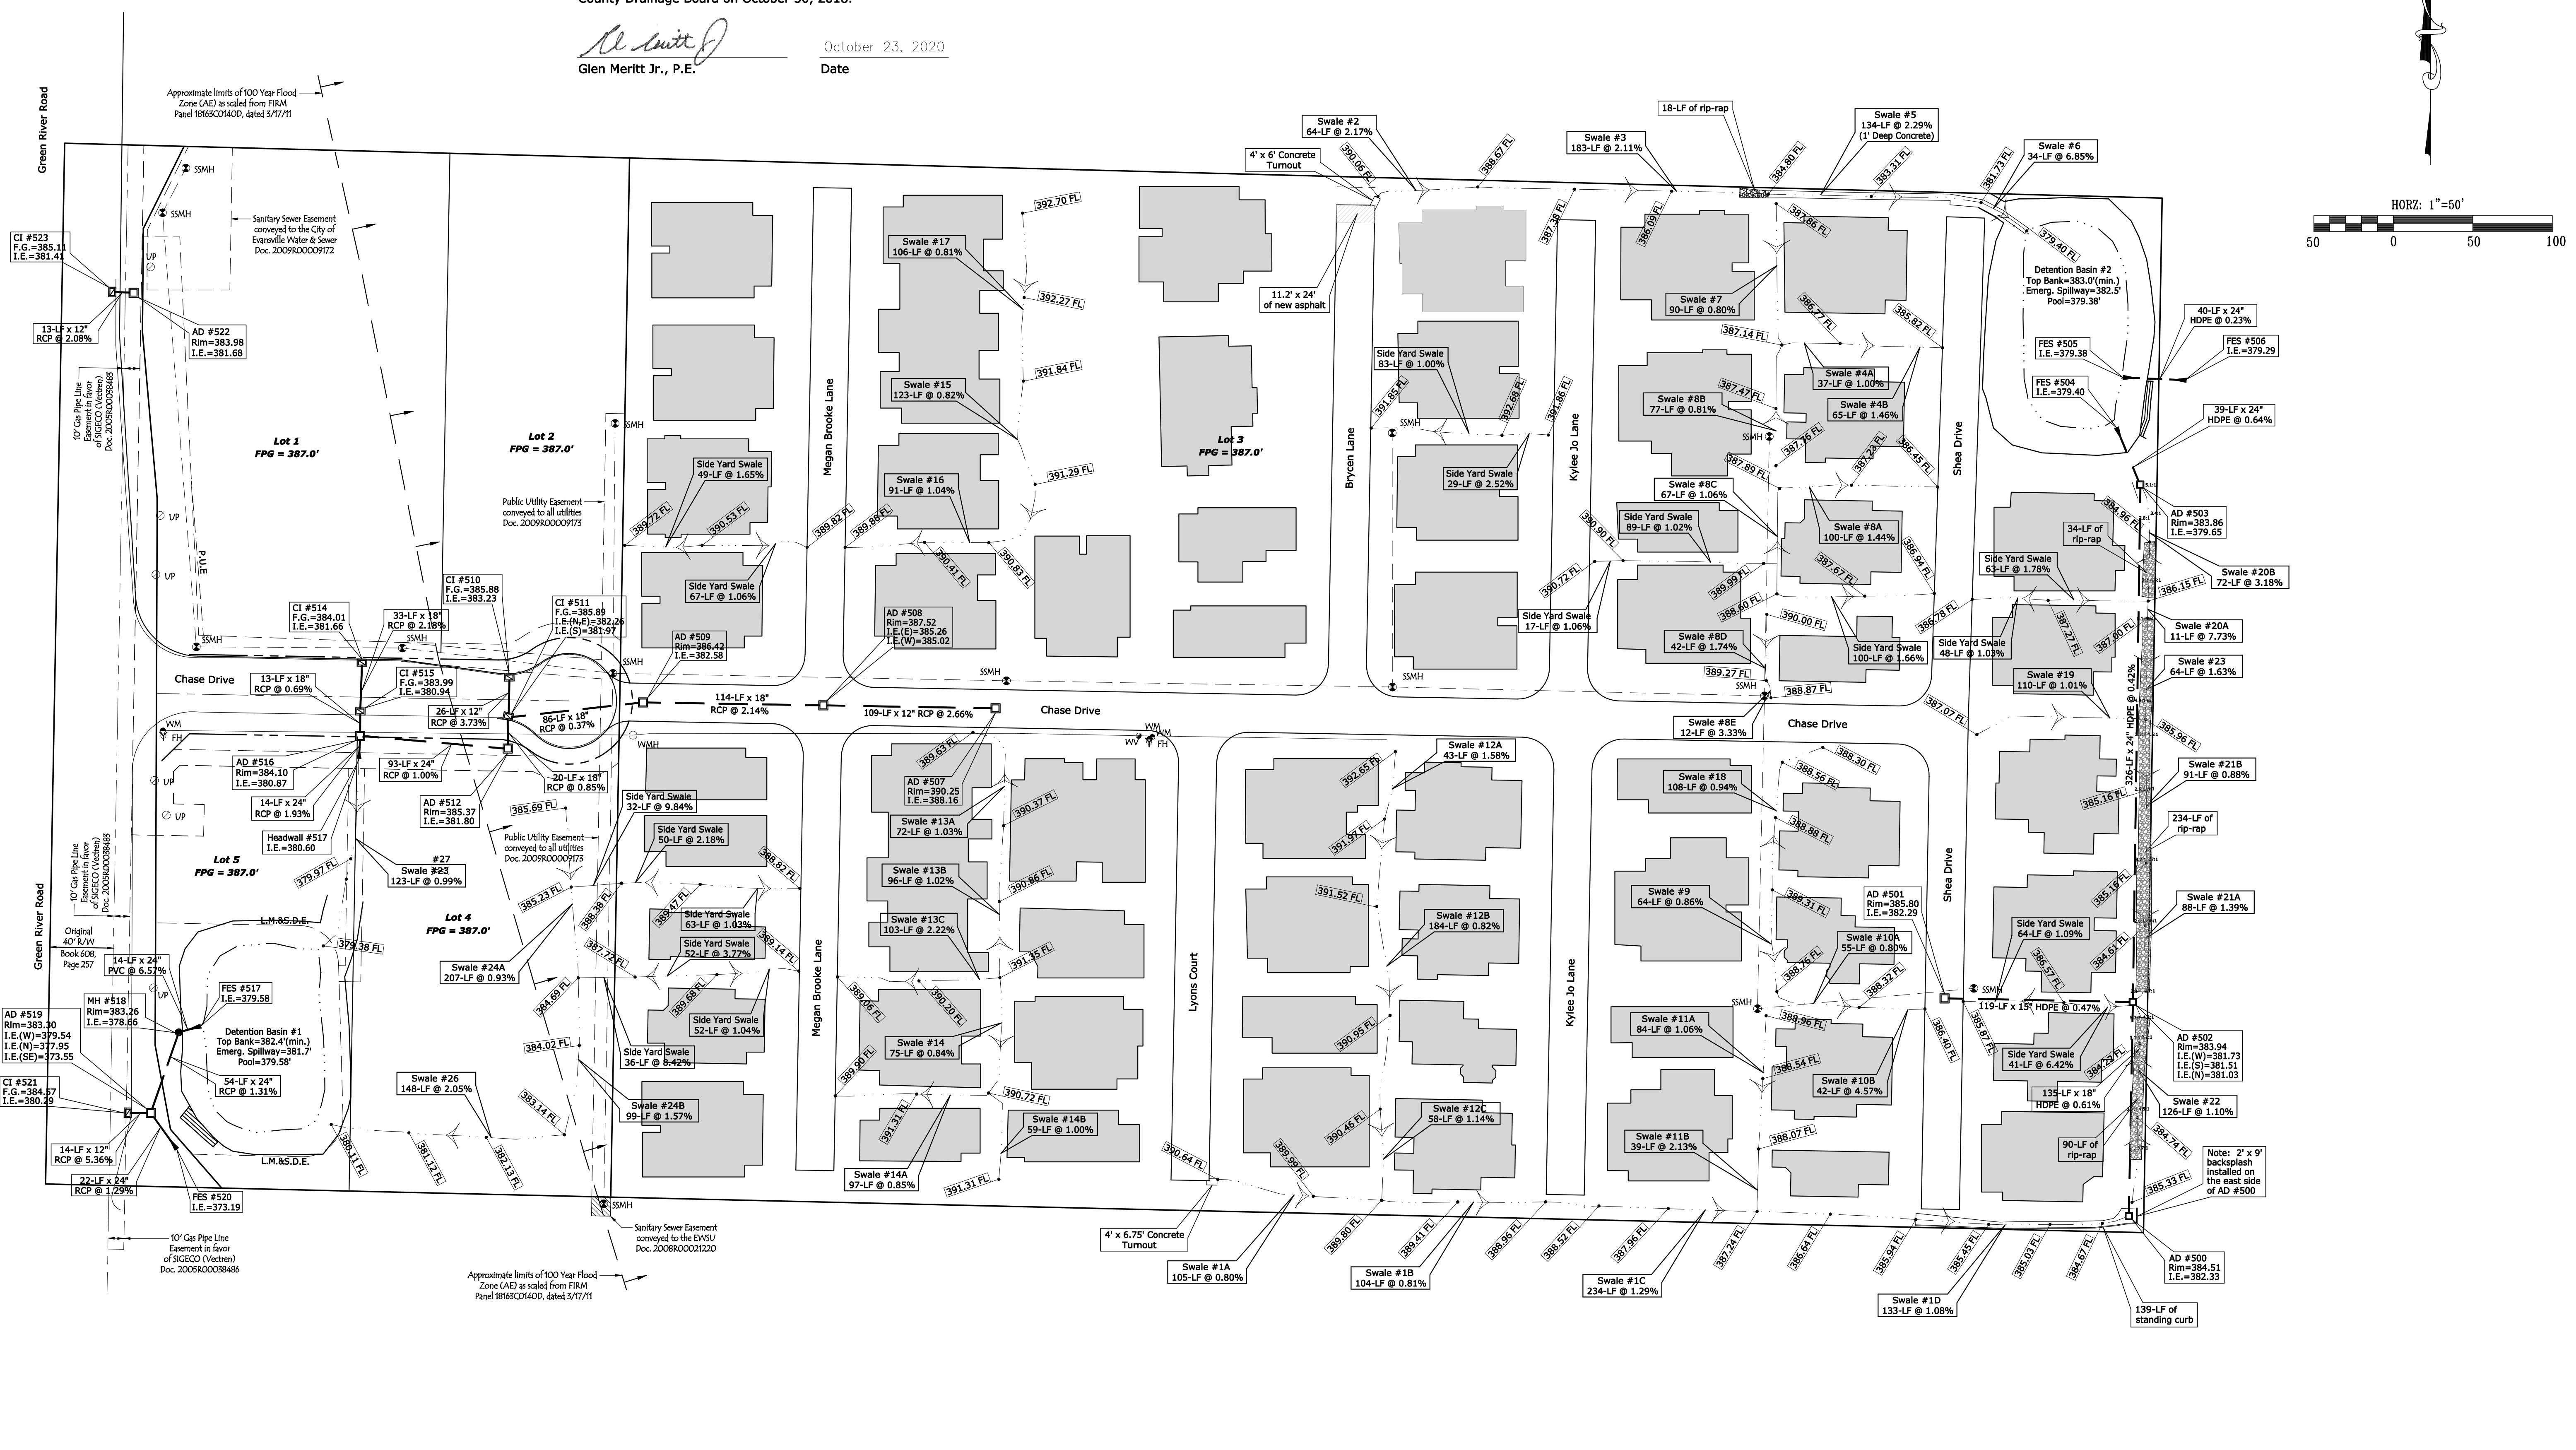


### Drainage Certification

The completed stormwater drainage system complies with the final drainage plans approved by the Vanderburgh County Drainage Board on October 30, 2018.

*Glen Meritt Jr., P.E.*  
Glen Meritt Jr., P.E.

October 23, 2020  
Date

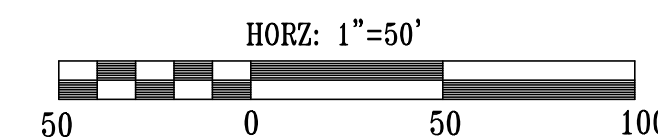

This drawing and/or specifications is provided as an instrument of service provided by Cash Wagner & Associates, PC and is intended for use on this project only. All drawings, specifications, designs, models, ideas, calculations, and arrangements appearing herein constitute the original and unpublished work of and remain the property of Cash Wagner & Associates, PC. Any reproduction, use or disclosure of the proprietary information contained herein without the prior written consent of the Cash Wagner & Associates, PC is strictly prohibited.

Written dimensions shown hereon shall take precedence over scaled dimensions. Contractors shall calculate and measure required dimensions. Notify Cash Wagner & Associates, PC with any variations in dimensions or conditions from those indicated on these drawings. This drawing was based on available information. Commencement of work constitutes verification and acceptance of existing conditions.

Application of a material or equipment to work installed by others constitutes acceptance of that work and assumption of responsibility for satisfactory installation.

*Glen Meritt Jr.*  
SIGNATURE

23 Oct 20  
DATE

**CASH WAGNER & ASSOCIATES, PC**  
CONSULTING | ENGINEERING | SURVEYING

414 CITADEL CIRCLE SUITE B  
EVANSVILLE, IN 47715  
PH: 812.401.5561  
FAX: 812.401.5563  
CELL: 812.774.2988  
E-MAIL: GMERITT@CASHWAGNER.COM

NO.	DATE	BY	DESCRIPTION
1	10.23.20	G.A.M.	Added backslash note at AD #500 & renumbered swale #23 between lots #4 & #5 to swale #27

PROJECT: HUNTER CHASE ESTATES  
ADDRESS: NORTH GREEN RIVER ROAD  
EVANSVILLE, INDIANA  
SHEET TITLE: DRAINAGE PLAN RECORD DRAWING

DATE: 08.21.20  
DRAWING NO.: C-101

PROJECT NO.: 14-1887  
DESIGNED BY: 1887 Asbuilt Base  
DRAWN BY: A.W.W.  
FILENAME: 1887 Asbuilt Base  
LAYOUT TAB: DRAINAGE  
SCALE: As Shown