


SCALES:
1" = 50' HOR
1" = 5' VER

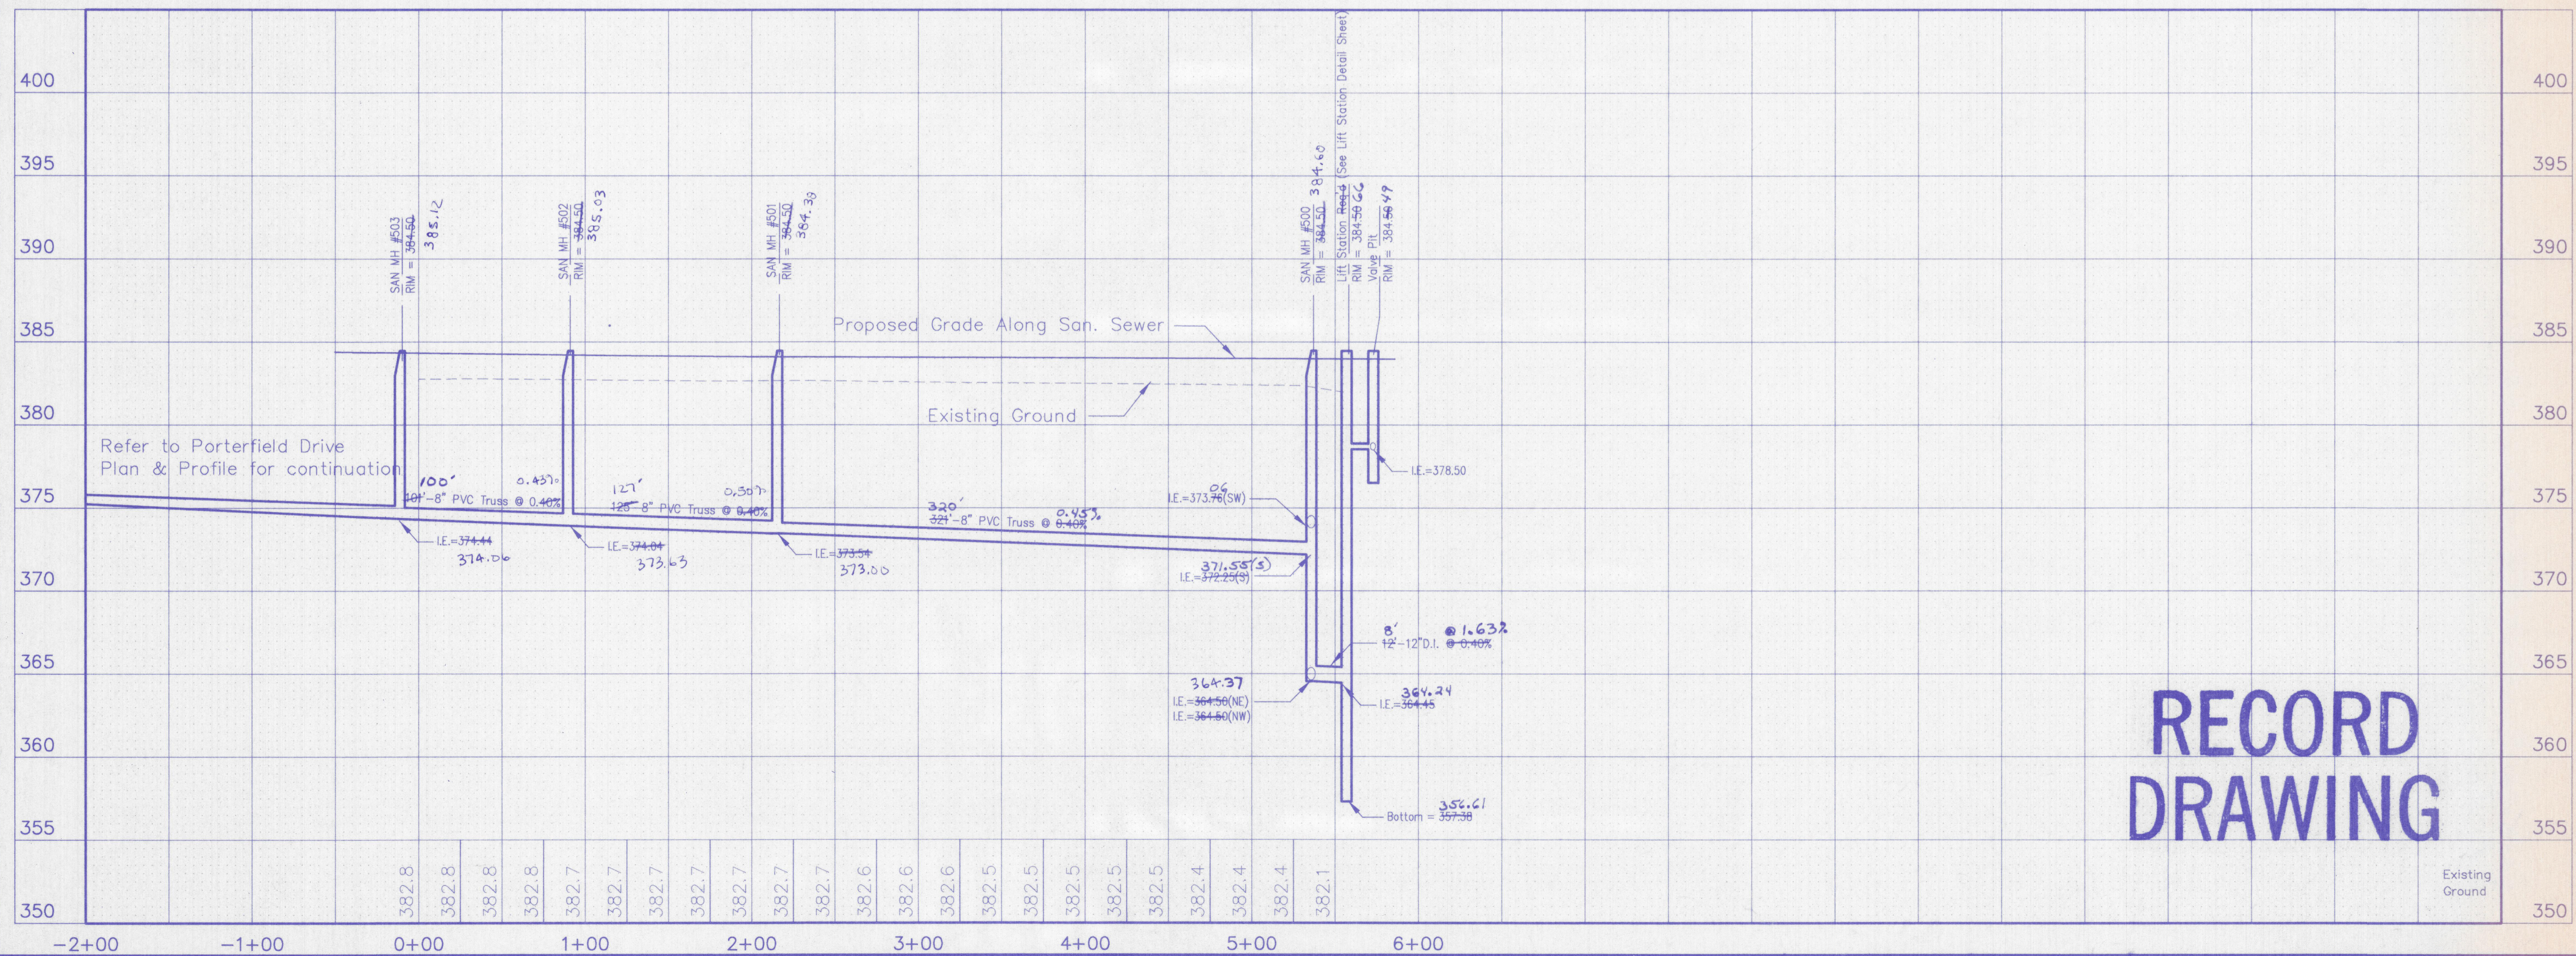

**RECORD
DRAWING**

Morley and Associates,
Consulting Engineers/Surveyors/Architects
600 S.E. Sixth Street
Evansville, Indiana, 47713
(812) 464-9585

Revisions	No.	By	Date	Description
	1	SH	6-1-10	SAN A-2 BUILTS

DAVID W. SCHWABE
REGISTERED PROFESSIONAL ENGINEER
No. 18500175
STATE OF INDIANA

Project: Keystone Section VII
Keystone Development, LLC
Sheet Title: San. Sewer Line "A" Plan and Profile
Scale: As Shown
Designed By: DWS Job Number: 3998-4
Drawn By: GAM Date: 9-19-00
Checked By: RCP Filename: RCp01008.dwg
Sheet Number: C-11 of 18