

Winstead Place Subdivision

Vanderburgh Co., Indiana

WINSTEAD PLACE BOX 8 D-4

DRAINAGE PLANS

APPROVED BY:
The Vanderburgh County
Drainage Board

BY: _____ DATE: _____

ROADWAY PLANS


APPROVED BY:
Board of County Commissioners
Vanderburgh County, Indiana

BY: *Steve Tom Jones* DATE: 3-9-98
Robert Johnson
David Jones

SANITARY SEWER PLANS

APPROVED BY:
Board of Evansville
Water and Sewer Utility

BY: _____ DATE: _____

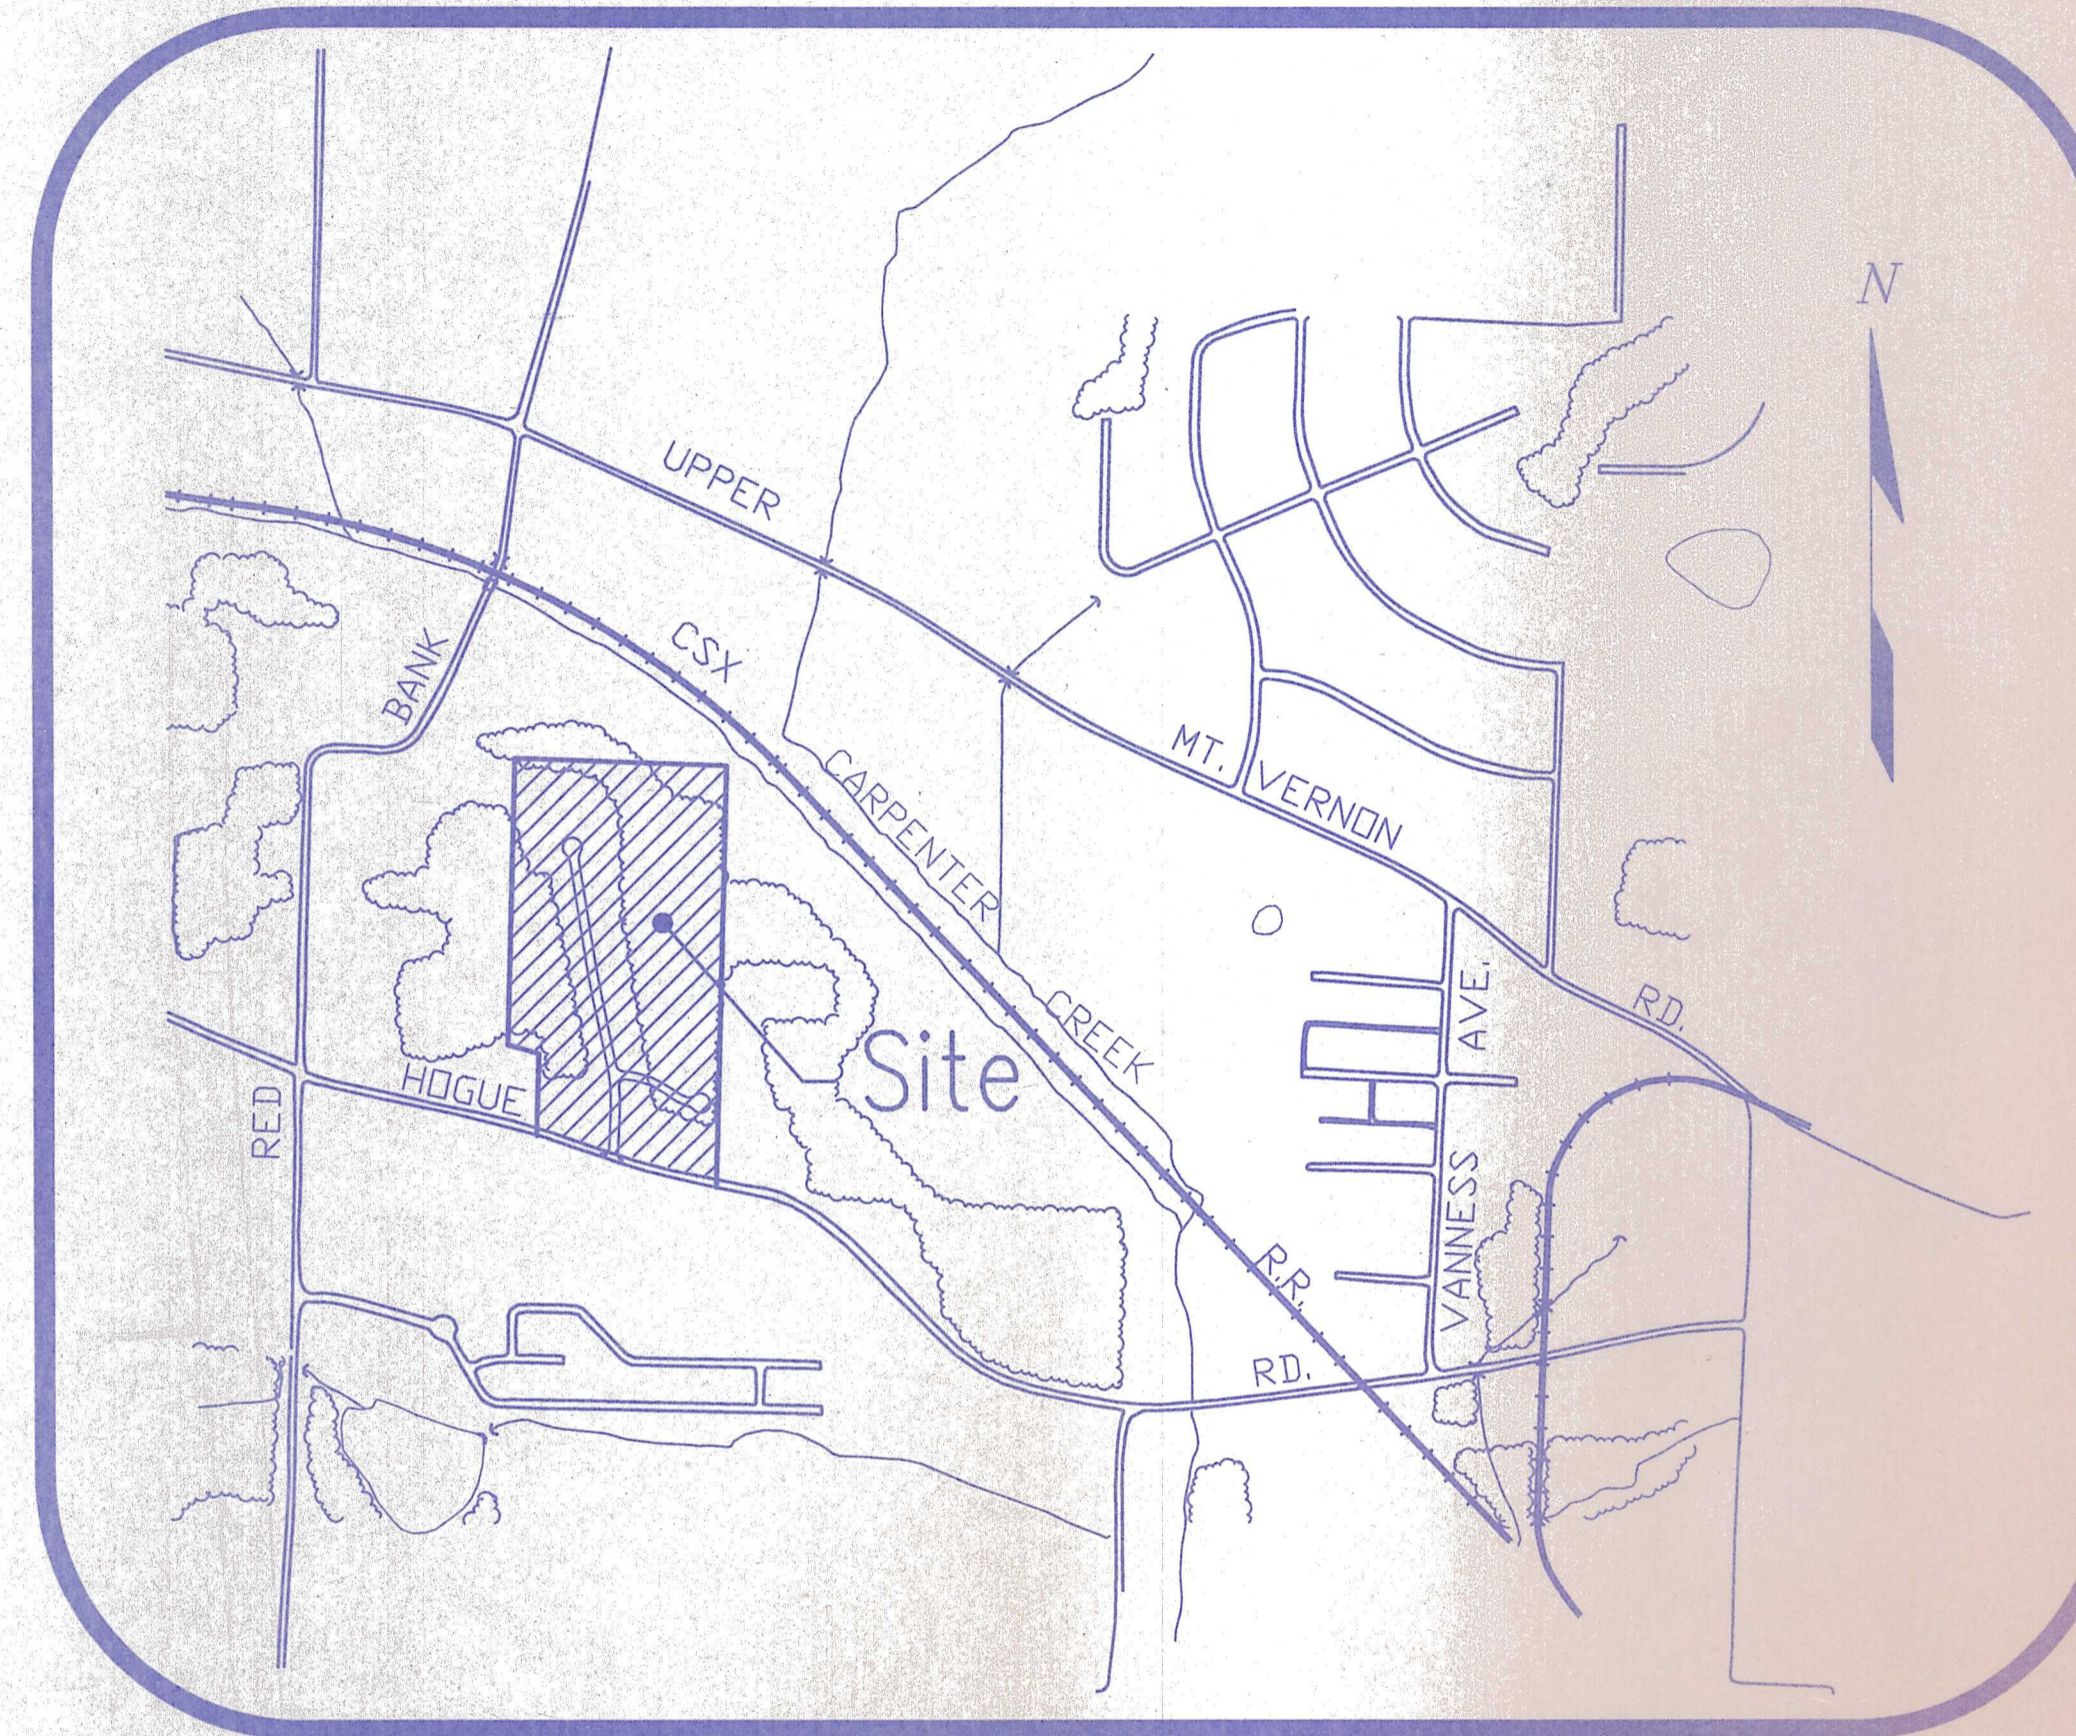

LOCATION MAP

Scale: 1" = 600'

SHEET INDEX:

Sheet #	Description
1	Cover, Index, Location Map
2	Plat Drawing
3	Drainage Plan
4	Storm and Sanitary Utility Plan
5	Road 1 Plan and Profile
6	Road 2 Plan and Profile
7	Plan and Profile - Sanitary Sewer Line "A"
8	Plan and Profile - Sanitary Sewer Line "B"
9	Sanitary Sewer Details
10	Storm Sewer Details
11	Road Details
12	Erosion Control Plan

OWNER:

Jerry Lamb
Prime Location Realtors
4111 Washington Avenue
Evansville, IN. 47714
(812) 474-7000

ENGINEER:

Morley and Associates

600 S.E. Sixth Street
Evansville, Indiana 47714
(812) 464-9585

RESOURCE LIST

ELECTRIC COMPANY:	SIGECO 20 N.W. Fourth Street Evansville, IN. 47741 1-812-464-4590 Attn.: Thomas Athipozhy	INDIANA UNDERGROUND PLANT PROTECTION SERVICES, INC. 1-800-382-5544
GAS COMPANY:	SIGECO 20 N.W. Fourth Street Evansville, IN. 47741 1-812-464-4635 Attn.: Bob Luttrell	VANDERBURGH COUNTY ENGINEERING DEPARTMENT Suite 307 - Old Court House 201 N.W. Fourth Street Evansville, IN. 47708 1-812-435-5773 Attn.: John Stall
TELEPHONE COMPANY:	AMERITECH 134 N.W. Sixth Street Evansville, IN. 47708 1-812-464-6050 Attn.: Marc Clark	VANDERBURGH COUNTY SURVEYORS OFFICE Room 325 - Civic Center Complex Evansville, IN. 47708 1-812-435-5210 Attn.: Bill Jeffers
WATER COMPANY:	EVANSVILLE WATER & SEWER UTILITY (EWSU) 1931 Allens Lane Evansville, IN. 1-812-421-2130 Attn.: Joe Lassack	VANDERBURGH COUNTY BUILDING COMMISSIONER Room 310 - Civic Center Complex Evansville, IN. 47708 1-812-426-5463 Attn.: Roger Lehman
SANITARY SEWER COMPANY:	EVANSVILLE WATER & SEWER UTILITY (EWSU) 1931 Allens Lane Evansville, IN. 1-812-421-2130 Attn.: Jim Williams	
CABLE TV COMPANY:	TCI CABLE 1900 N. Fares Ave. Evansville, IN. 1-812-422-1167 Attn.: Don Baumholser	

Existing Utilities are shown in their approximate locations on the drawings. The Contractor shall notify all utilities before beginning work for field locations. The utilities to be notified include but are not limited to the following:


- Southern Indiana Gas and Electric Co.
- Evansville Water and Sewer Utility
- Ameritech Telephone Co.
- TCI Cable Television Co.

The following Governmental agencies shall be notified 24 hours prior to beginning work and on a daily basis thereafter when performing the work listed below:

- Storm Sewers, street subgrade, and streets
Vanderburgh County Engineer
- Sanitary Sewers
Evansville Water and Sewer Utility Operations Department

The contractor is cautioned that the location and/or elevation of existing utilities as shown on these plans is based on records of various utility companies, and where possible measurements taken in the field. The information is not to be relied on as being exact or complete. The contractor must contact the appropriate utility company at least 48 hours before any excavation to request exact field location of utilities.

Indiana Underground Utility Locate Service,
Phone: 1 (800) 382-5544

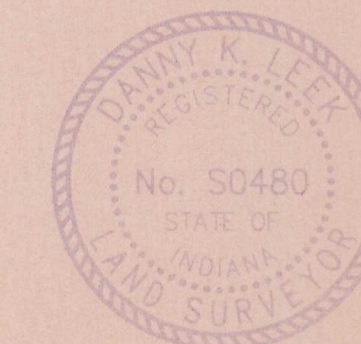

Danny K. Leek
Indiana Registration No. 50480

Date: _____

February, 1998

Winstead Place

Box 8 D-4