


ASBUILT OF LATERAL LOCATIONS

LOT #	DOWNSTREAM M.H.	DISTANCE TO M.H.	DISTANCE OFF LINE
15	520	48.5	3.4
16	520	8.15	6.4
17	517	72.7	5.2
77	517	13.5	5.1
78	516	55	4.4
79	504	180.8	1.9
80	504	104.9	2.5
81	504	37.7	3.3
82	504	41.5	3.7
83	504	116.6	4.4
84	504	194	3
85	504	257.8	0.18
86	504	305.6	3.8

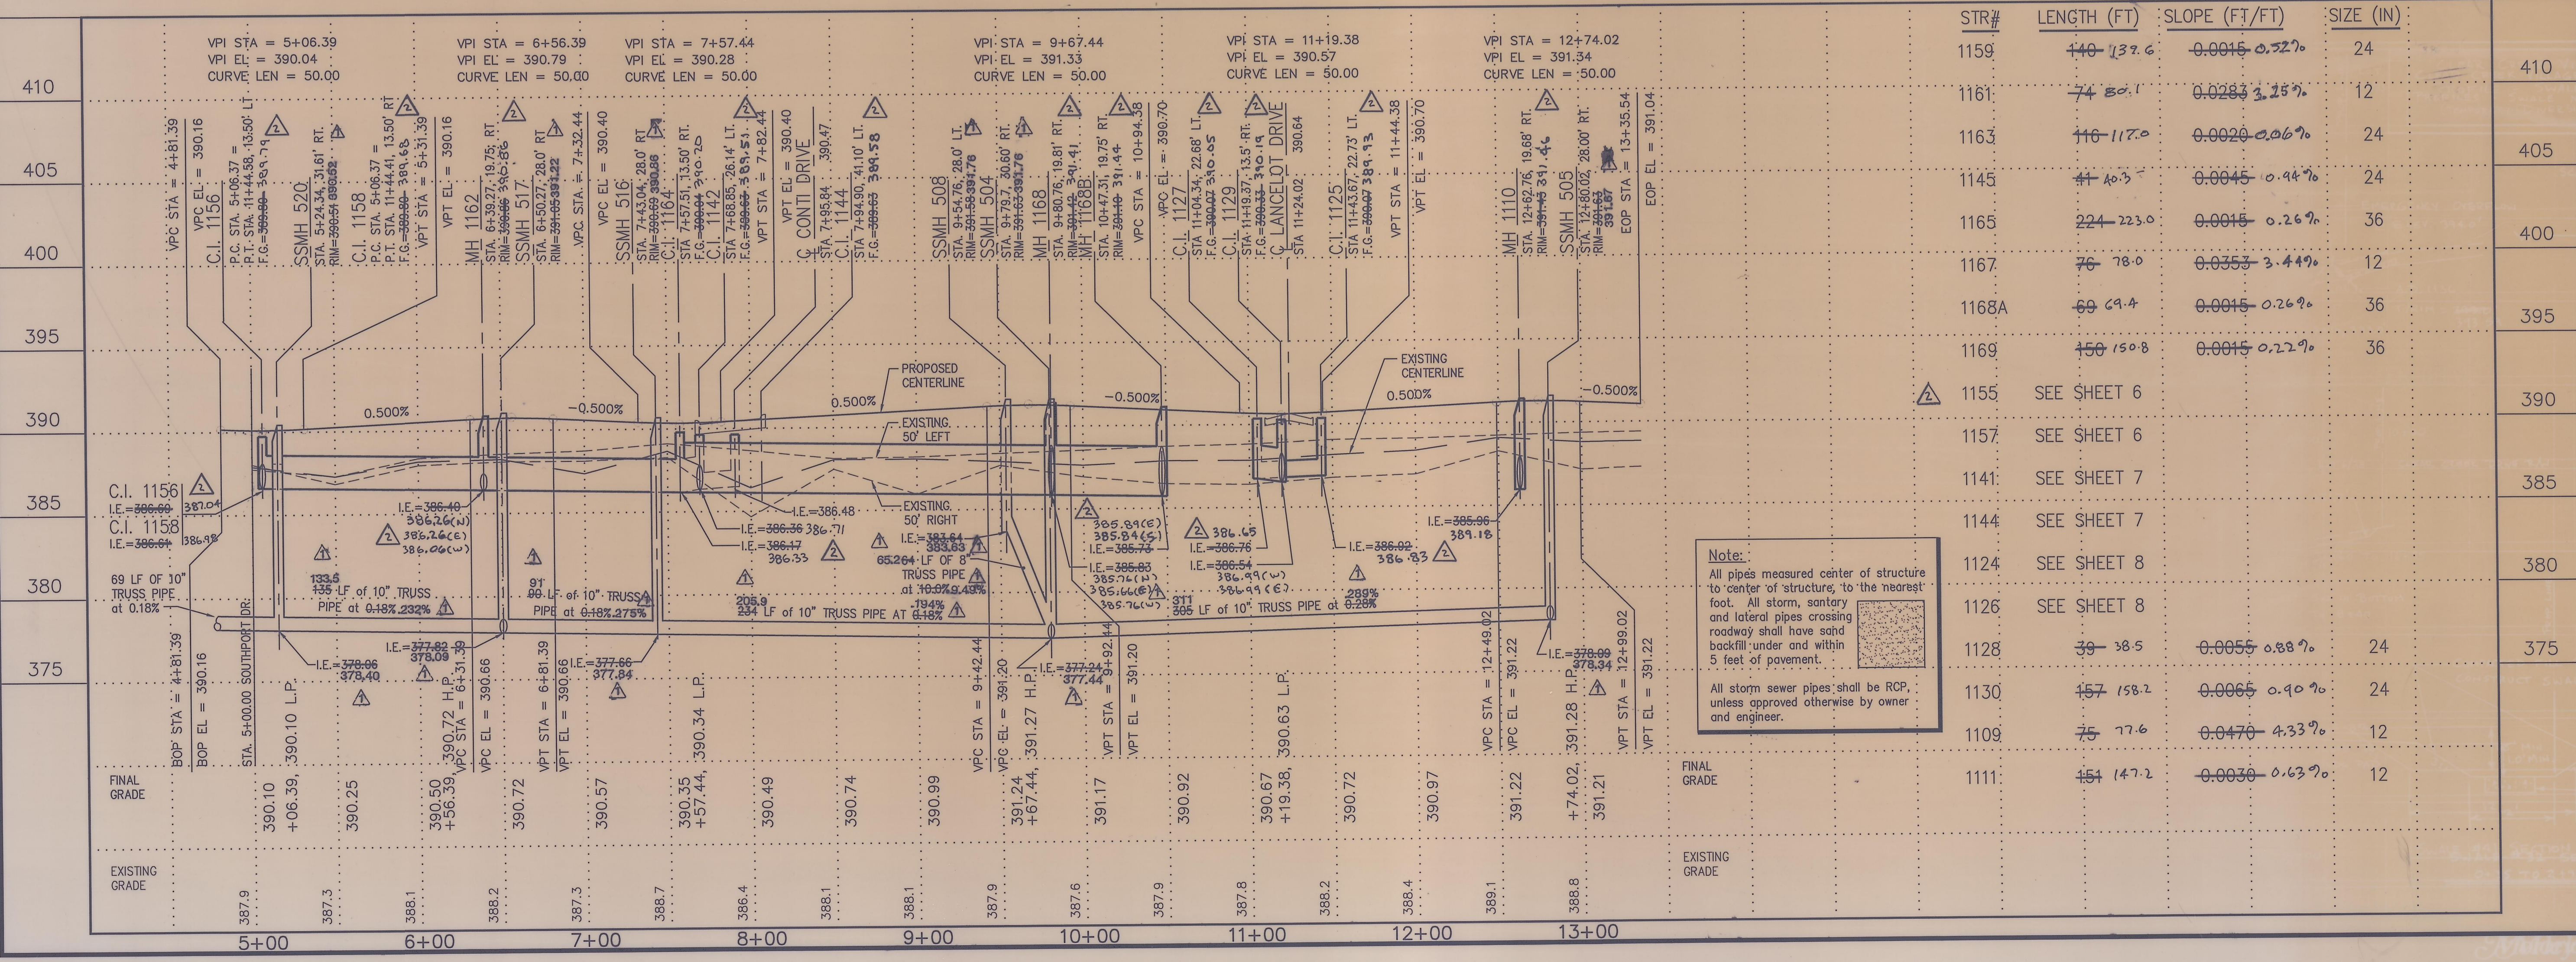

**Morley and Associates, Inc.**  
 Consulting Engineers/Surveyors/Architects  
 605 S.E. Martin Luther King Jr. Blvd.  
 Evansville, Indiana 47713  
 (812) 464-9666

Revisions

No.	By	Date	Description
1	JEM	5/21/18	Sanitary Sewer As Built Phase 1

Project: Clear Creek Village - Section 1  
 Sheet Title: Southport Drive Plan and Profile

Scale: 1"=50'HORZ.  
 1"=5' VERT.

Designed By: JEM Job Number: 3309-1  
 Drawn By: CAH Date: 09-27-96  
 Checked By: JEM Filename: RCP01005.DWG  
 Sheet Number: 9 of 16

Professional Engineer Seal: JAMES O. MORLEY, No. 13817, STATE OF INDIANA