


STRUCTURE DATA TABLE

STRUCTURE NUMBER	LOCATION	LET	SIZE	DESCRIPTION	FLOW LINE		ELEVATION
					UP	DOWN	
Station	Station	Station	Station		ft.	ft.	ft.
FES 887		X	15				217
P-886	PEBBLE STONE	X	15				
FES 885		X					
FES 884		X					
P-883-D		X	15				78
C-883-C		X					
P-883-B	FLANSTONE DR	X					63
C-883-A		X					
P-883		X	15				69
FES 882		X					
SANCTUARY COURT							
FES 881	34+48.50	X					138
P-880	44+86.50	X	18				
P-878		X					53
C-875	54+39.50	X					
P-876		X	12				27
C-877	54+39.50	X					
C-875	54+39.50	X					
P-874		X	24				312
C-869	84+52.00	X					
AD-873	84+52.00	X					152
P-872		X	15				
C-870	84+52.00	X					
P-870		X	12				27
C-869	84+52.00	X					
P-868		X	30				180
C-867	104+28.59	X					
P-866		X	30				168
AD-865		X					80
C-864		X					
AD-863		X					
PEBBLE PLACE COURT							
C-850	124+93.49	X					
C-849		X	12				27
C-848	124+93.49	X					
P-847		X	30				150
AD-846	124+93.49	X					
BRAYDEN DRIVE							
C-818	74+68.00	X	12				27
P-818		X					
C-817	74+68.00	X					
P-816		X	30				145
AD-810	74+68.00	X					
AD-809		X					73
P-808		X					
AD-827	124+19.85	X					46
P-826		X					
MH-825	124+19.85	X					136
C-824		X					
C-823	114+74.81	X					
P-822	114+74.81	X					27
C-821	114+74.81	X					
C-814	154+72.62	X					
P-813		X					27
C-812	154+72.62	X					
P-811		X					145
AD-810	154+72.62	X					
FLANSTONE DRIVE							
C-808	374+83.41	X					
P-807	PEBBLE STONE	X					86
C-804	384+82.89	X					
P-805		X					27
C-806	384+82.89	X					
C-804	384+82.89	X					120
P-803		X					
AD-802	404+05.41	X					198
P-801		X					
FES-800	404+05.41	X					
C-844	414+31.43	X					
P-843	BRAYDEN DR	X					80
C-840	424+13.42	X					
C-842	424+13.42	X					
C-840	424+13.42	X					
P-839		X	120				
AD-838	434+30.60	X					79
C-837		X					
C-834	444+03.40	X					
P-833		X	27				
C-832	444+03.40	X					
P-831		X	183				
FES-830	444+05.64	X					
C-836	414+31.43	X					
P-832	PEBBLE STONE	X					72
C-834	444+03.40	X					
FES 863-D							
FES 863-D	514+62.17	X					19
AD-863-B	514+47.04	X					170
P-831-A		X					
AD-863	484+31.70	X					158
P-862		X					
C-856	484+20.82	X					28
P-856		X					
C-857	484+11.42	X					163
P-856		X					
FES 855	484+11.42	X					

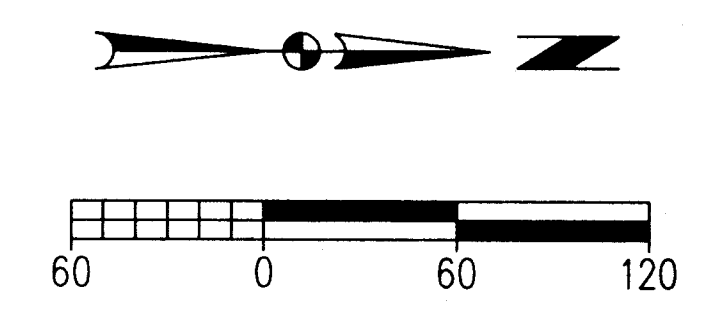

Morley and Associates, Inc.
 Consulting Engineers/Surveyors/Architects
 605 S.E. Martin Luther King Jr. Blvd.
 Evansville, Indiana 47713
 (812) 464-8685

Utility Plan

Project: Keystone Subdivision Section V
 Sheet Title: Utility Plan
 Scale: 1" = 60'
 Designed By: D.W.S. Job Number: 3098-4(F)
 Drawn By: G.A.H. Date: 02-10-97
 Checked By: Plemm Sec5.dwg
 Sheet Number: 3 of 16