



Location Map
Scale: 1"=1000'

Stonecreek PUD
Section 2, Phase 1
Plat Book Q, page 118

Granfield Court



Lot 312 Lot 310

Lot 311

Lot 273 Lot 274

Stonecreek PUD
Section 2, Phase 1
Plat Book Q, page 118

Open Space

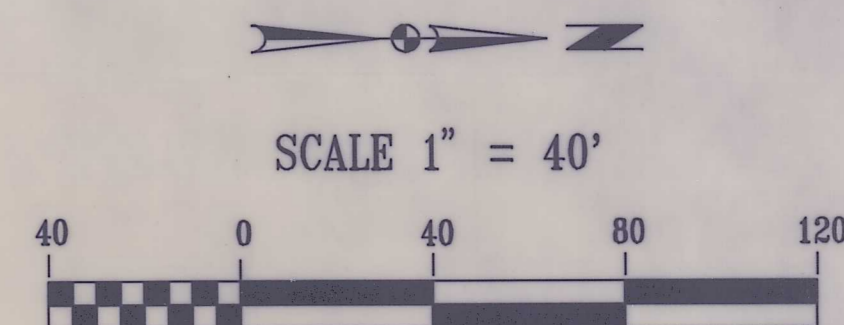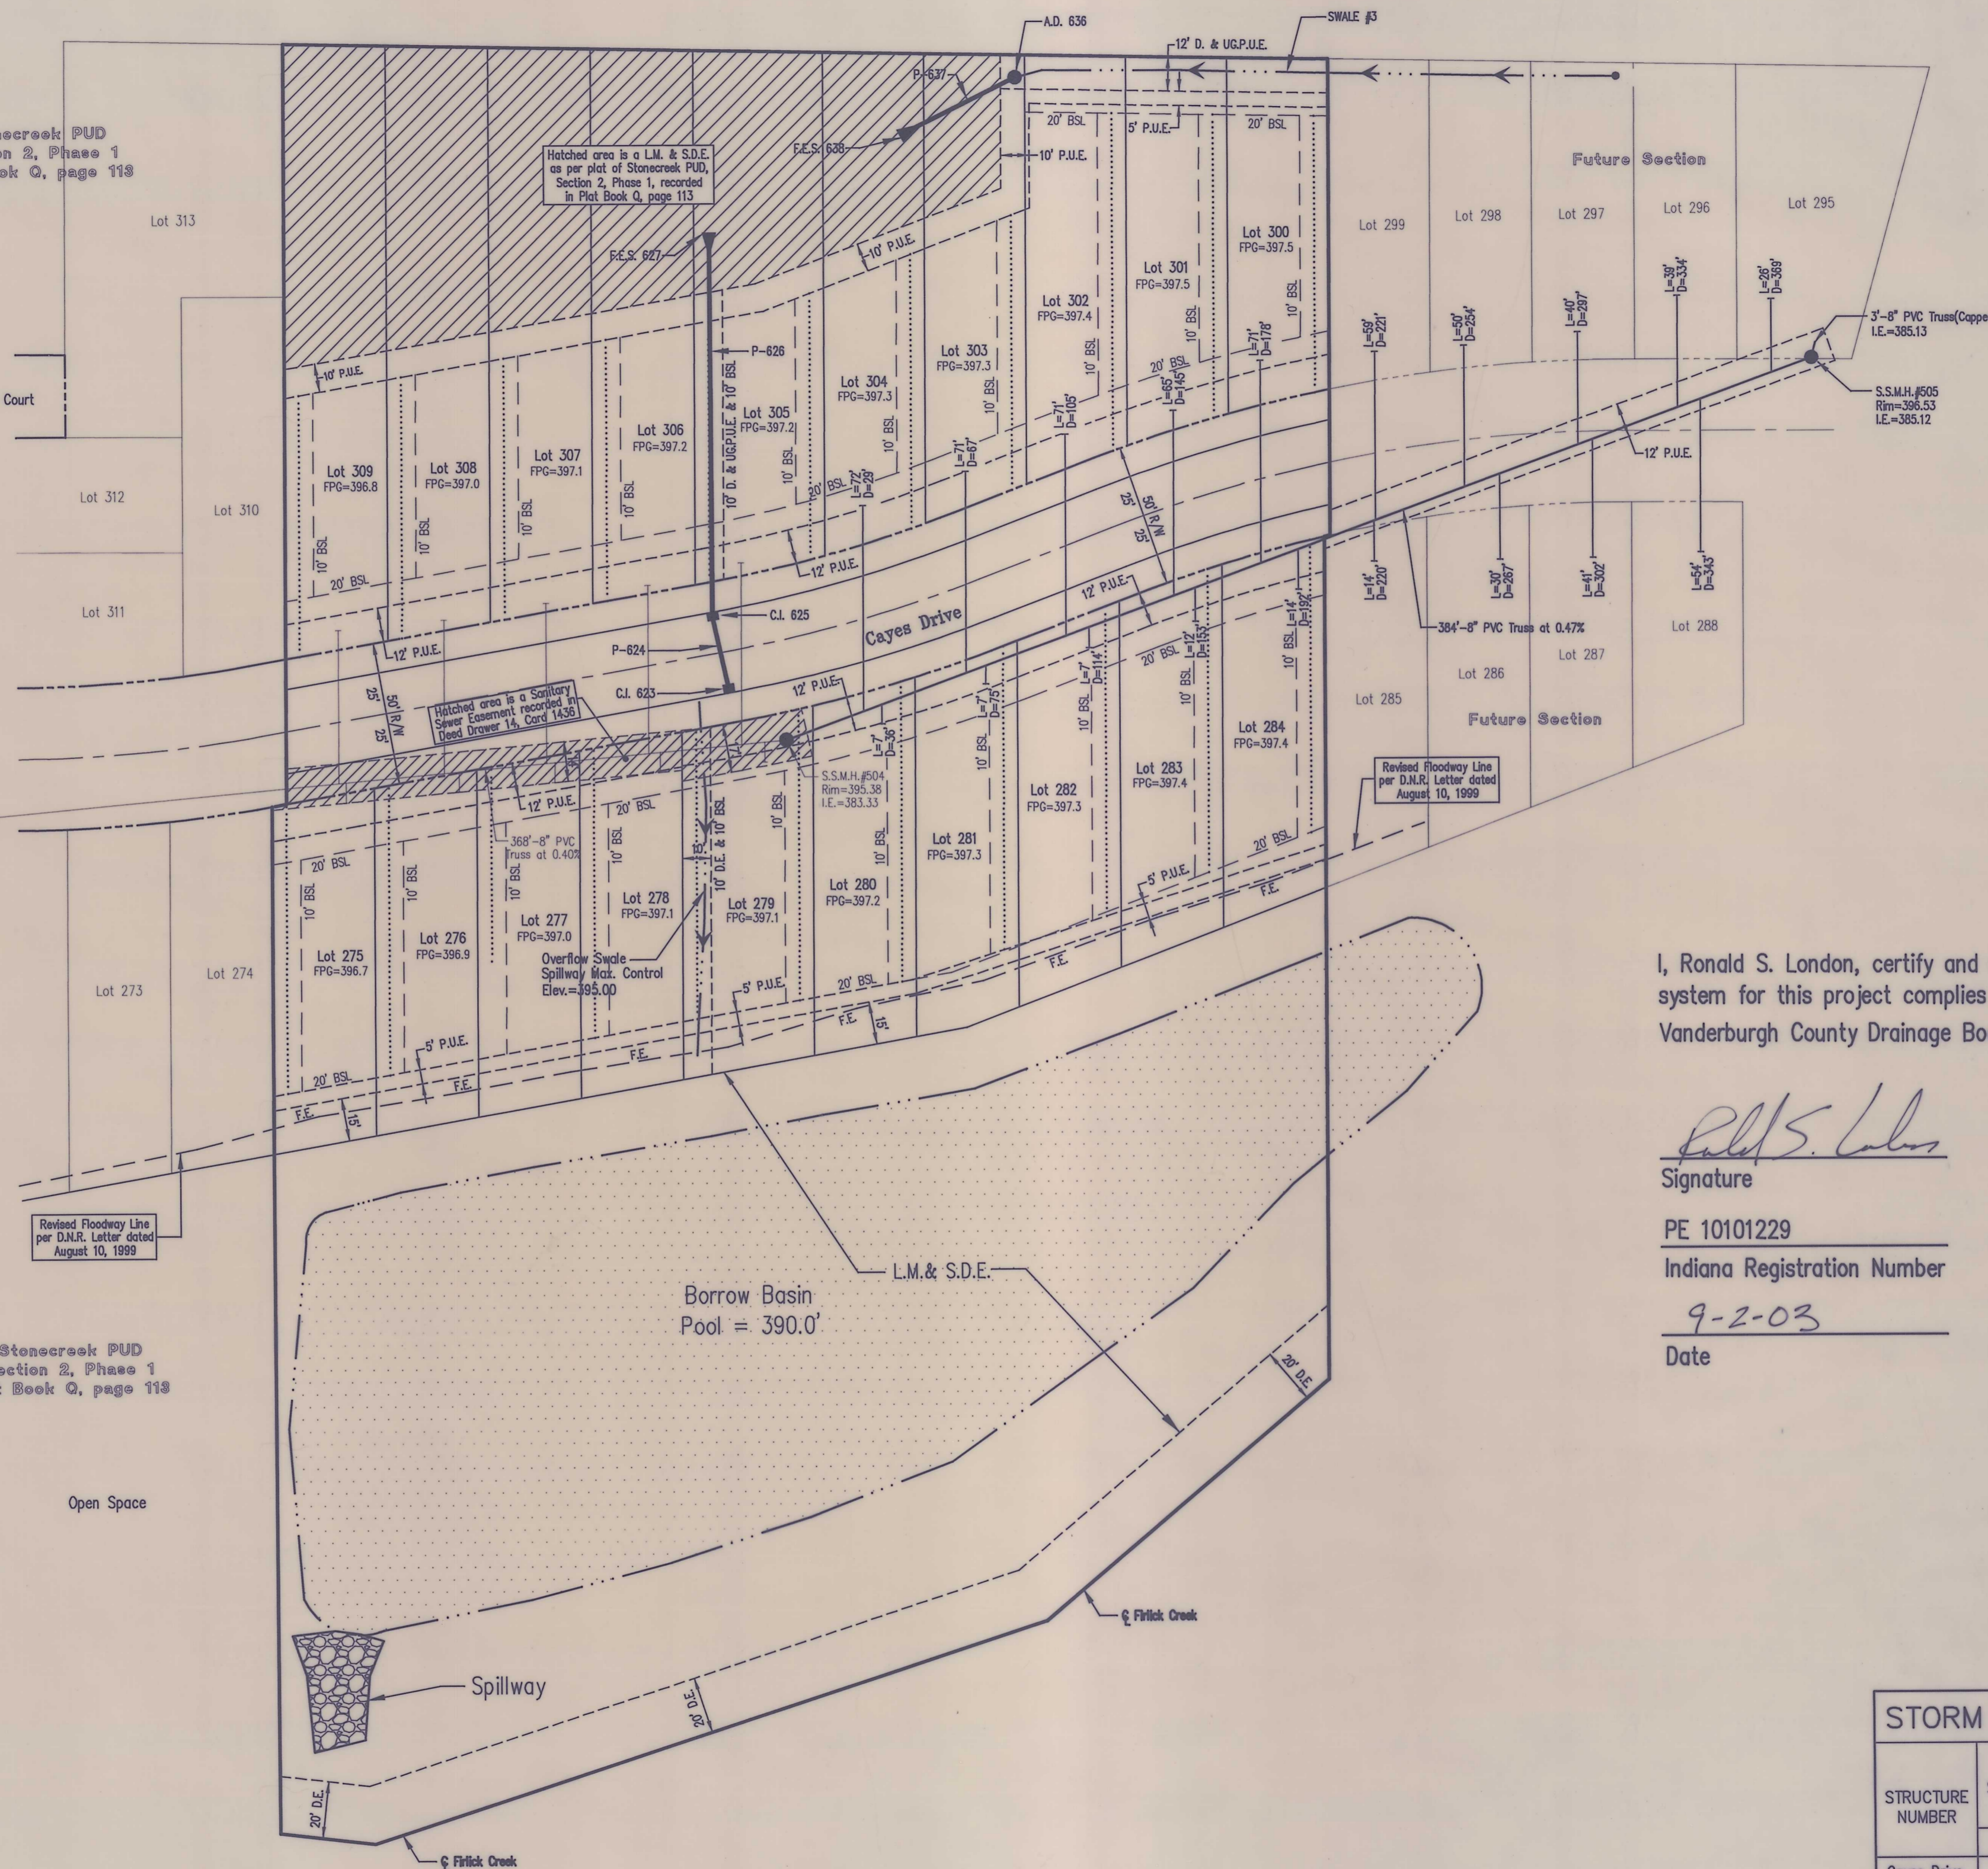

SANITARY SEWER
LATERAL INDEX

L = LENGTH OF LATERAL
D = DISTANCE OF LATERAL TO DOWNSTREAM MANHOLE

DRAINAGE SWALE DATA TABLE

SWALE NUMBER	LENGTH	SLOPE	FLOW LINE		16"x8" CONCRETE RIBBON
			UP STREAM	DOWN STREAM	
	ft.	%	Elev.	Elev.	
3	211	0.55	395.46	394.31	YES

STORM STRUCTURE DATA TABLE

STRUCTURE NUMBER	SIZE	LENGTH	FLOW LINE		SLOPE	FES = IE AD = Rim or CI = FL Elev.
			UP STREAM	DOWN STREAM		
	in.	ft.	Elev.	Elev.	%	Elev.
Cayes Drive						394.42
C.I. 623						394.42
P-624	12	26	392.16	392.01	0.58	
C.I. 625						394.38
P-626	15	129	392.01	390.65	1.05	
F.E.S. 627						390.59
A.D. 636						394.31
P-637	18	39	391.54	390.73	2.09	
F.E.S. 638						390.60

NOTE: ALL PIPE ARE R.C.P. UNLESS OTHERWISE NOTED

I, Ronald S. London, certify and affirm that the completed storm water drainage system for this project complies with the Final Drainage Plan as approved by the Vanderburgh County Drainage Board.

Ronald S. London
Signature

PE 10101229
Indiana Registration Number
9-2-03
Date

Morley and Associates, Inc.
Consulting Engineers/Surveyors/Architects
600 S.E. Sixth Street
Evansville, Indiana 47713
464-9585

All ideas, designs, calculations, and arrangements indicated or represented by this drawing are intended for the use on and in connection with the specified project. None of such ideas, designs, calculations, or arrangements shall be used by or disclosed to any other person without the written permission of Morley and Associates, Inc. Written dimensions on these drawings shall have precedence over all other dimensions shown on the job and Morley and Associates, Inc. must be notified of any variations from the dimensions and conditions shown by these drawings.

No.	By	Date	Description

Project: Stonecreek P.U.D. Section 2 - Phase 2
Sheet Title: Utility/Drainage Plan Record Drawing
Scale: 1" = 40'
Designed By: R.S.L. Job Number: 4255-4(H)
Drawn By: S.A.M. Date: 9/2/03
Filename: 4/4255/Ch2/BASE/RECORD.PLOT
Sheet Number: 1